


LEFT ELEVATION

E-1 1/4"=1'-0"

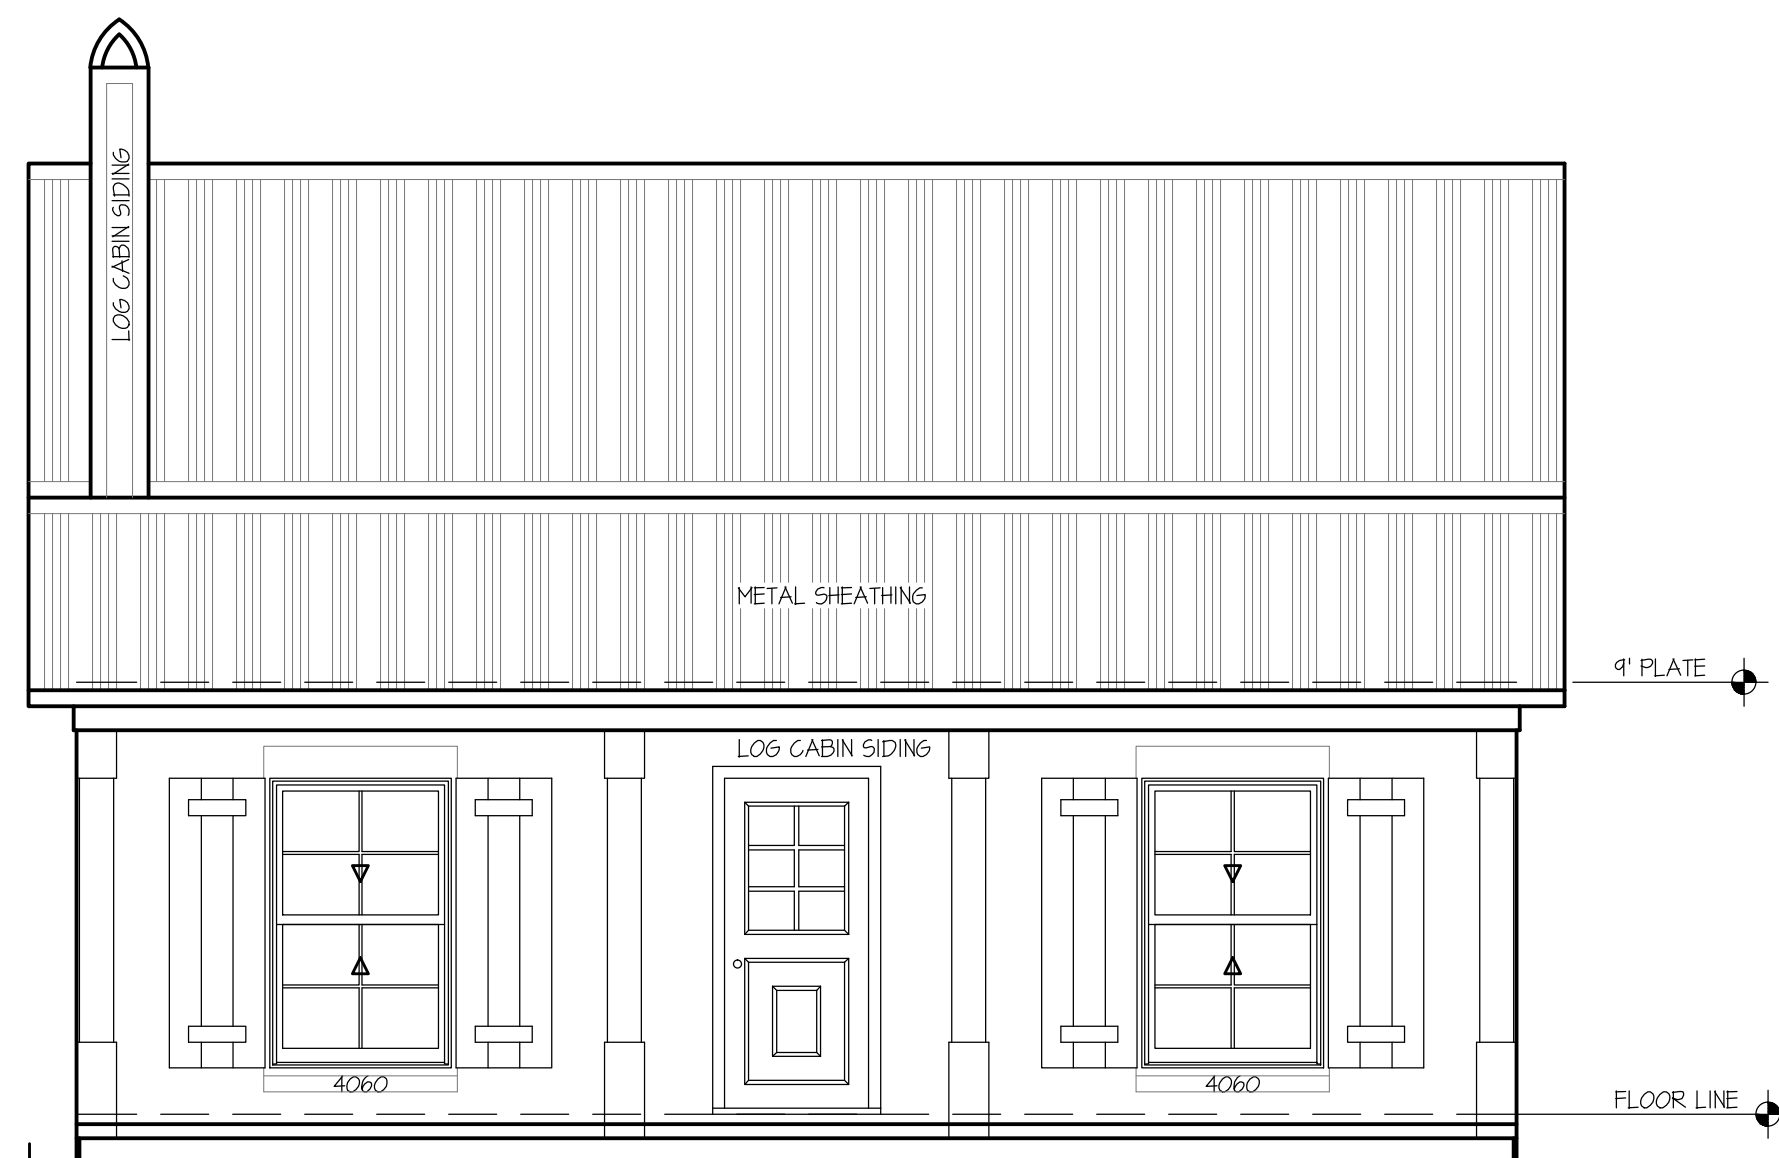


FRONT ELEVATION

E-1 1/4"=1'-0"

ELECT. SYMBOLS LEGEND

	110V DBL. RECEPTACLE		SINGLE POLE SWITCH
	220V DBL. RECEPTACLE		THREE WAY SWITCH
	CEILING MOUNTED FIXTURE		FOUR WAY SWITCH
	HALL MOUNTED FIXTURE		PHONE JACK
	RECESSED LIGHT FIXTURE		TELEVISION JACK
	RECESSED EYE BALL		HOSE BIB
	EXHAUST/FAN/LIGHT UNIT		FUEL GAS
	DOOR BELL		SENSOR LIGHT
	CEILING FAN		SMOKE DETECTOR
	52" CEILING FAN W/ LIGHT KIT		FLORESCENT LIGHTING

NOTE:
 LIVING AREA -----1260
 FRONT PORCH ----- 240
 TOTAL AREA -----1500

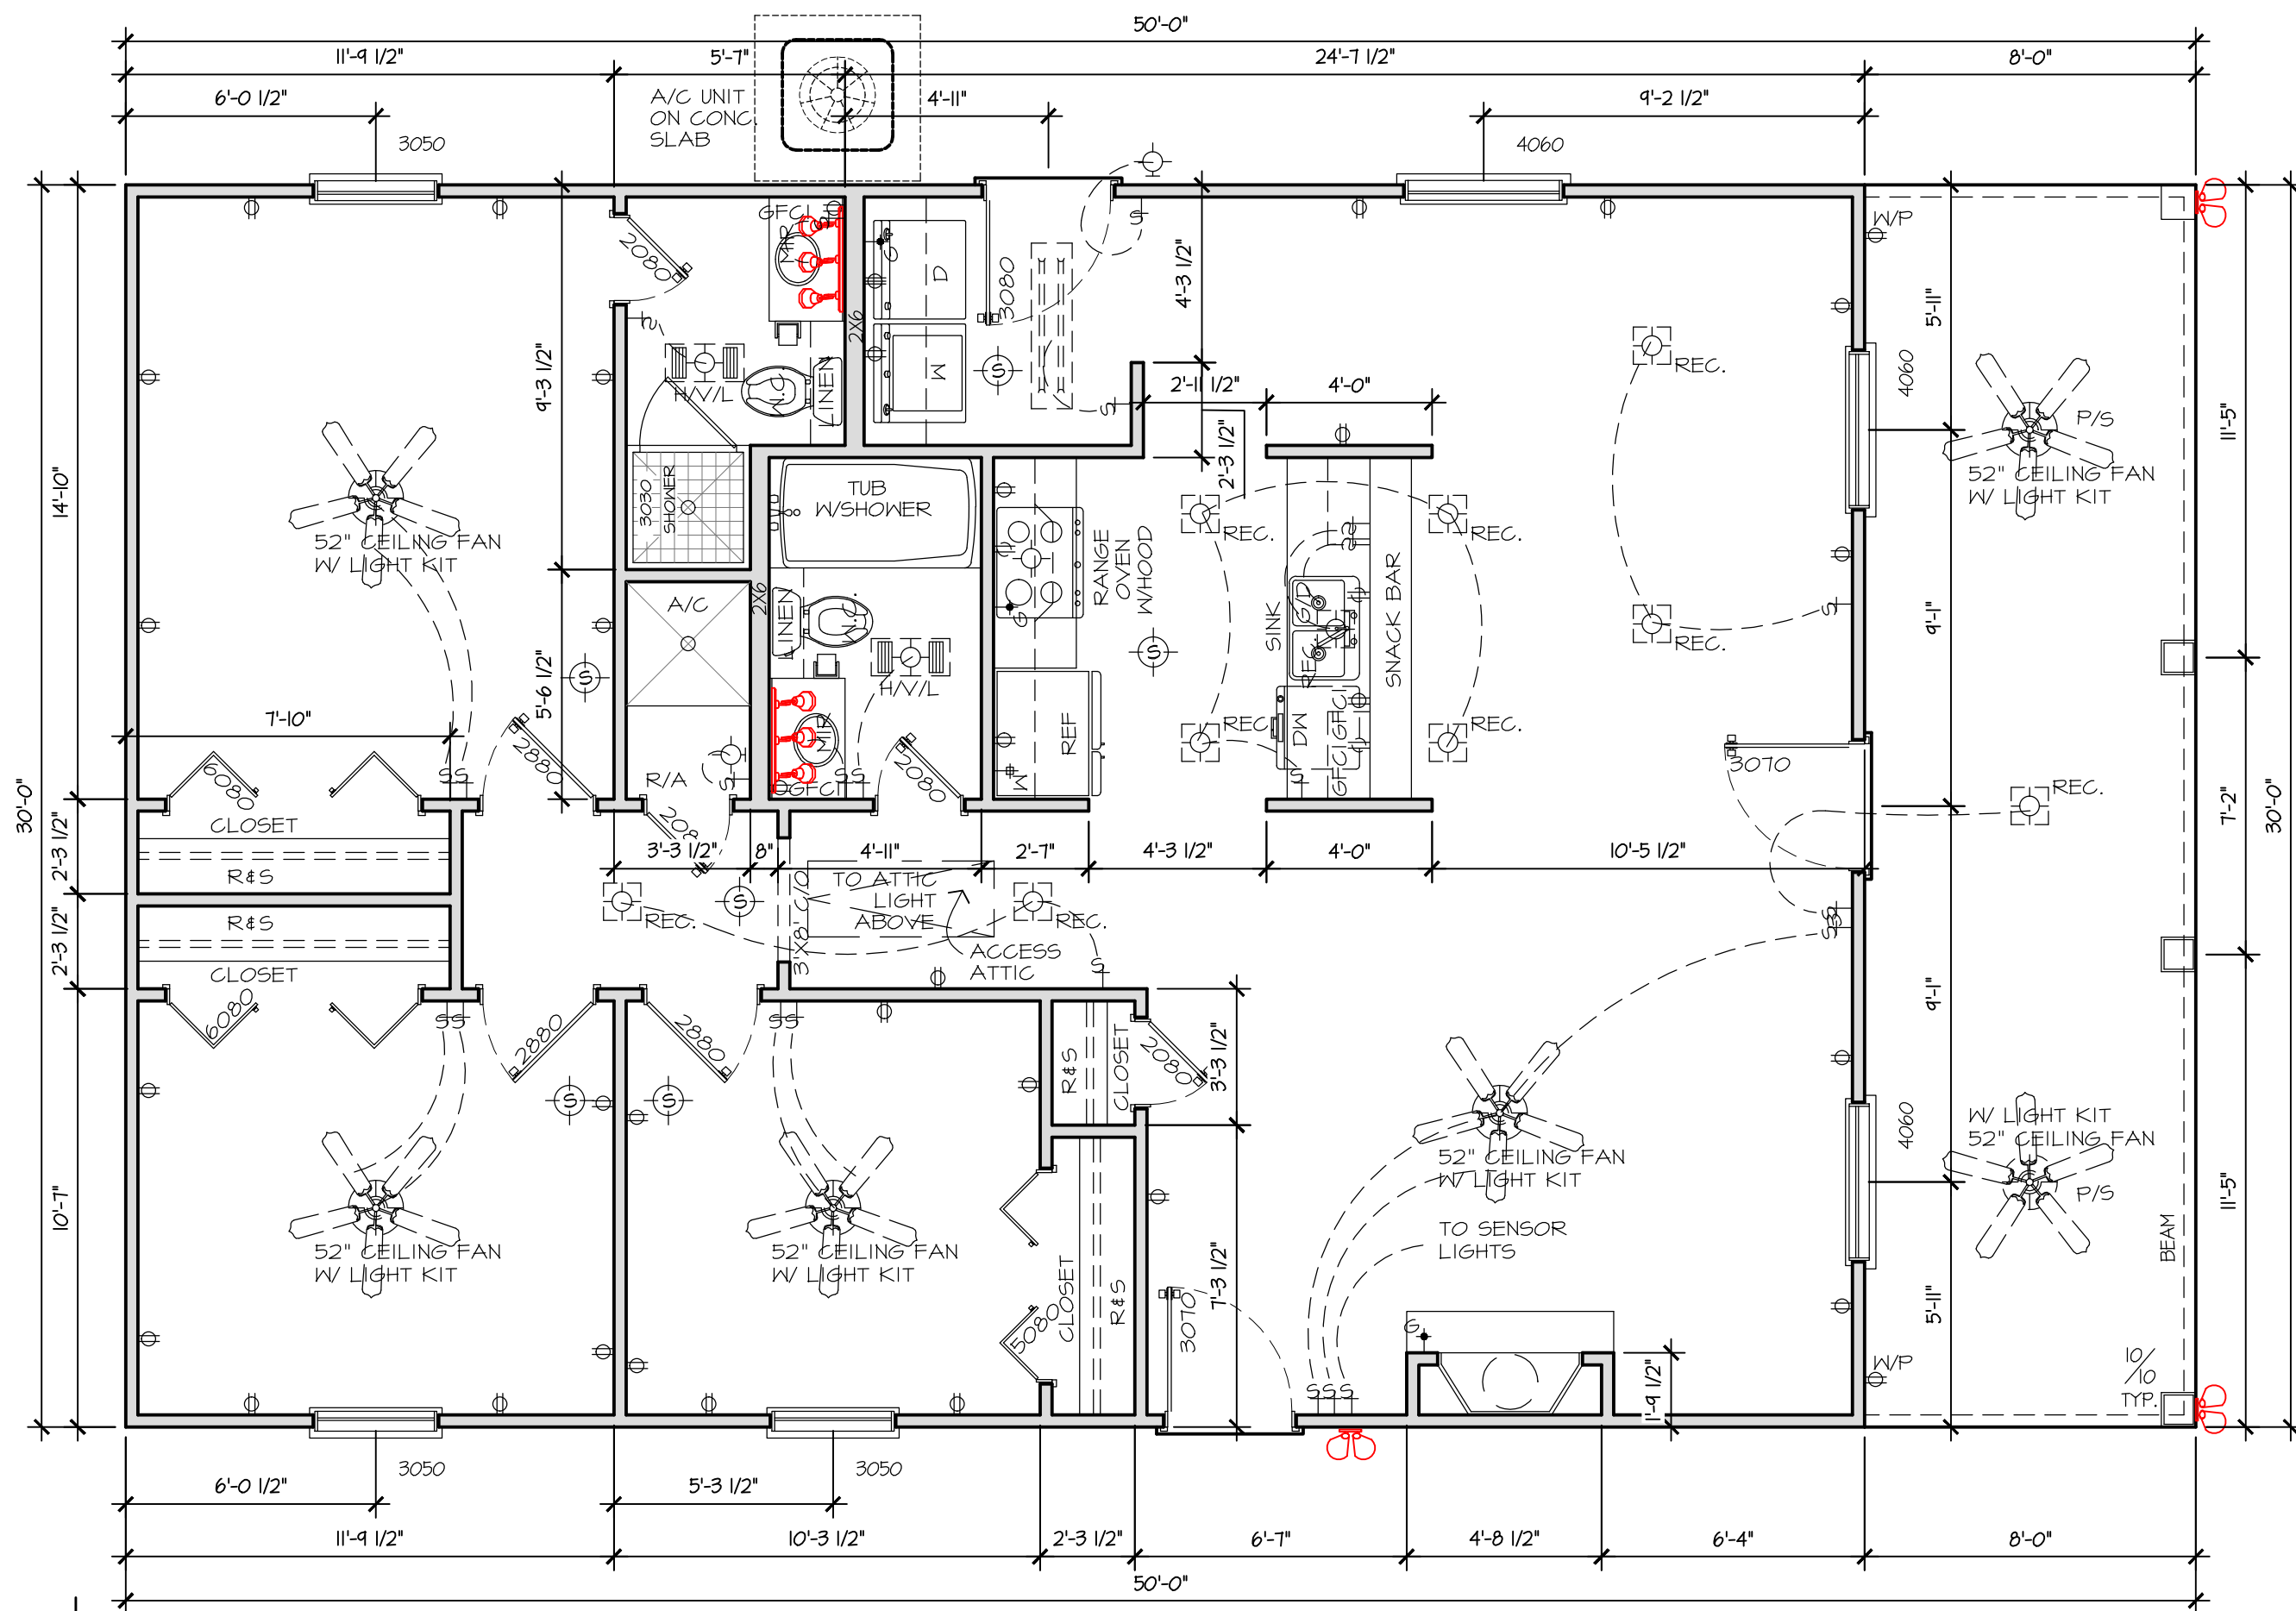


FLOOR PLAN

F-1 1/4"=1'-0"

Revisions:


Revised By:

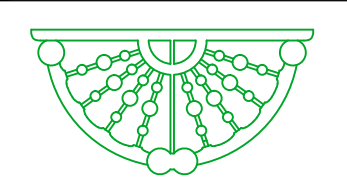

ELEVATIONS & FLOOR PLAN

LAFAYETTE, LA

PROJECT

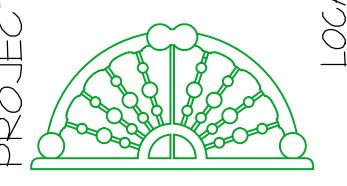

LOCATION:

THIS DRAWING AND/OR ANY OTHER DRAWING, IN WHOLE OR IN PART, REMAINS THE SOLE PROPERTY OF C.A.D. Unlimited, Inc. ANY MEANS OF REPRODUCTION, WHETHER MECHANICAL OR OTHERWISE IS FORBIDDEN, AND ANY VIOLATIONS WILL BE PROSECUTED TO THE FULLEST EXTENT OF THE LAW. THIS DRAWING IS PROTECTED BY THE "FOUR-CORNER DOCTRINE". THIS DRAWING IS AUTHORIZED COPYING OF DRAWING IN WHOLE OR IN PART, MAY ONLY BE DONE BY WRITTEN AUTHORIZATION FROM THE OWNER/DESIGNER OF C.A.D. Unlimited, Inc.



100 CANYON RIDGE
 LAFAYETTE, LA. 70506
 (337) 984-3382
 CADDRAWING1@COX.NET

NO.:32400TEFA
 DATE : 10/1/16
 SCALE: NOTED
 JOB : DRoger
 SHEET : 1 of 2

